

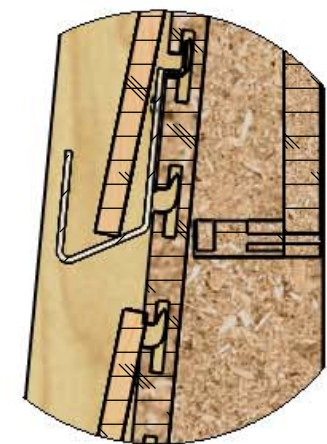
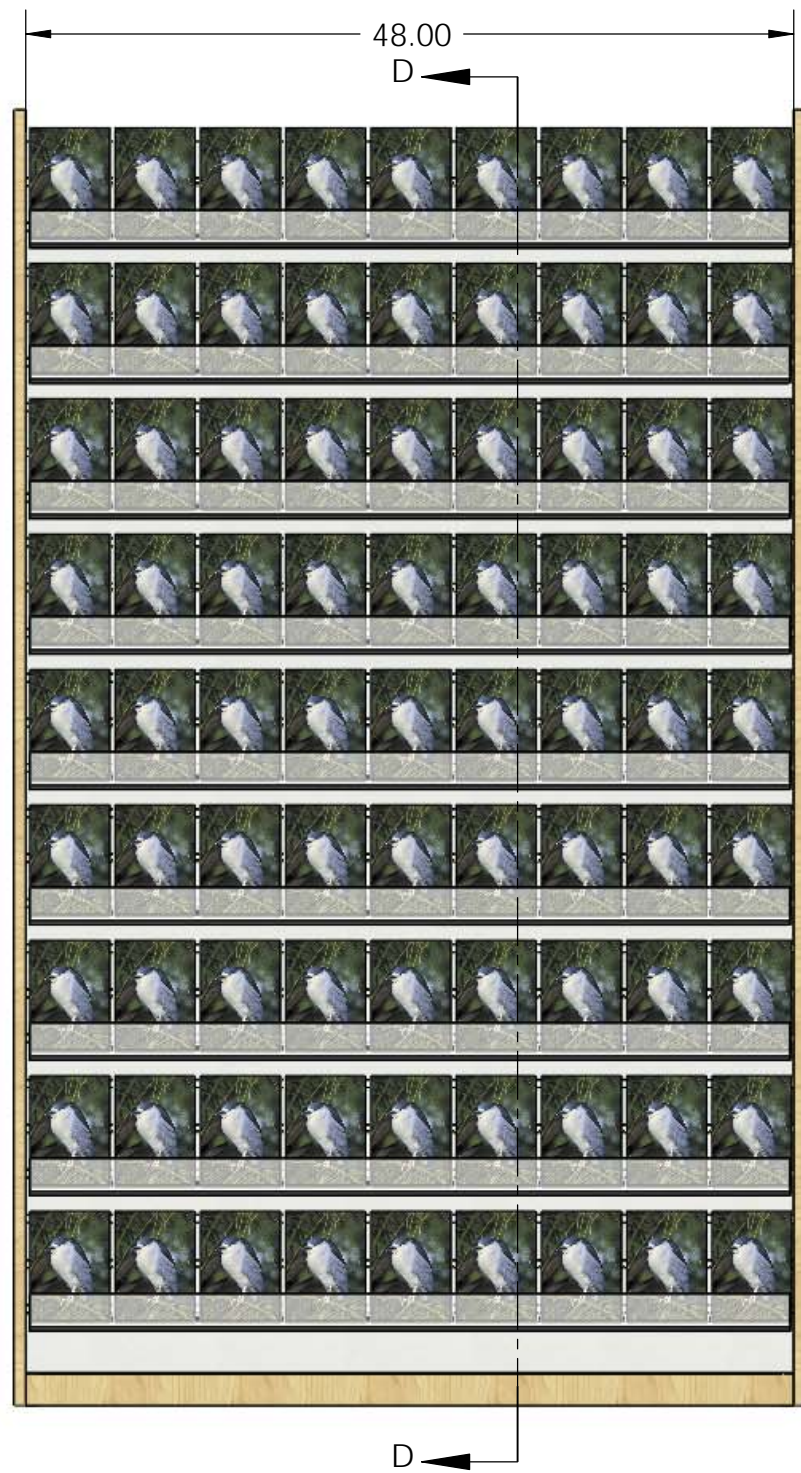


SSI CARD WALL			
			QTY:
DR.BY: <i>CSC</i>	SCALE:1:12	7/24/2009	1

Divider Fin Sold Separately

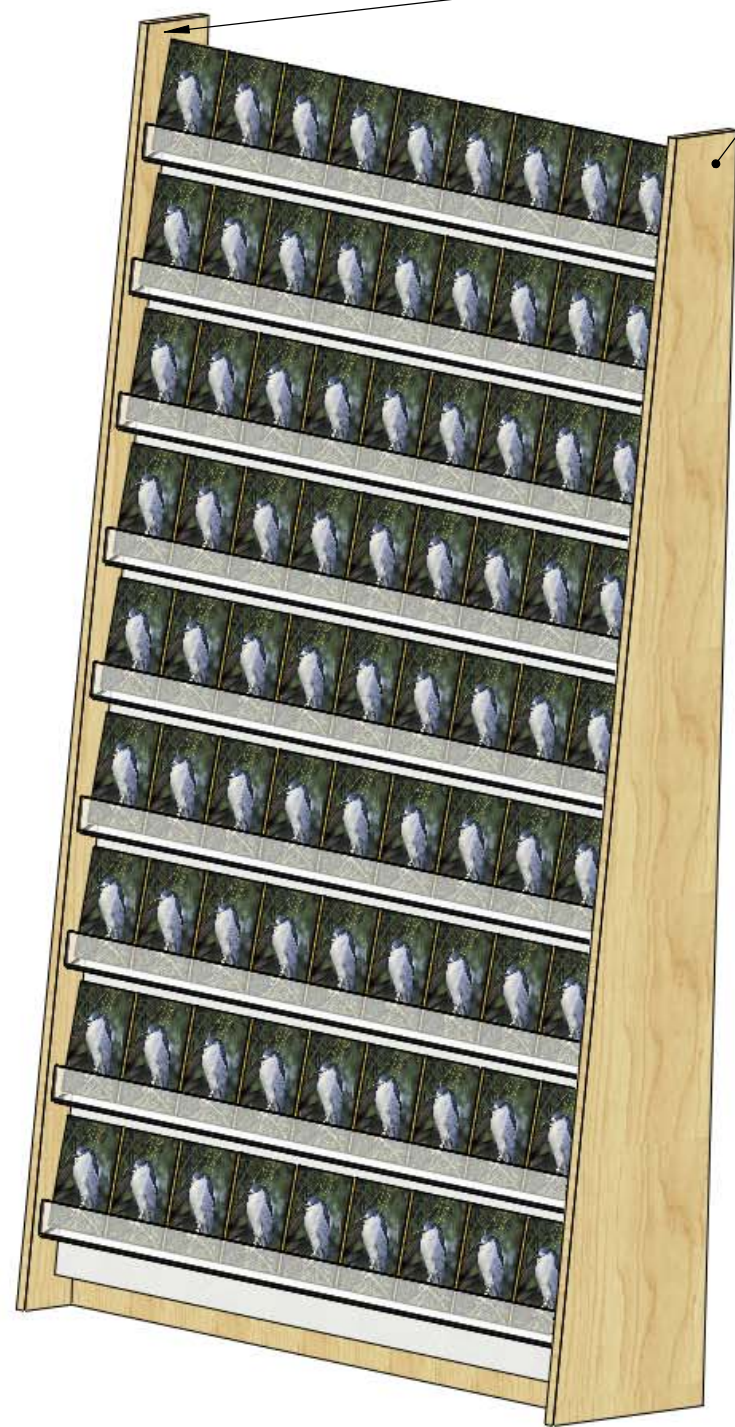

DETAIL E  
SCALE 1 : 4

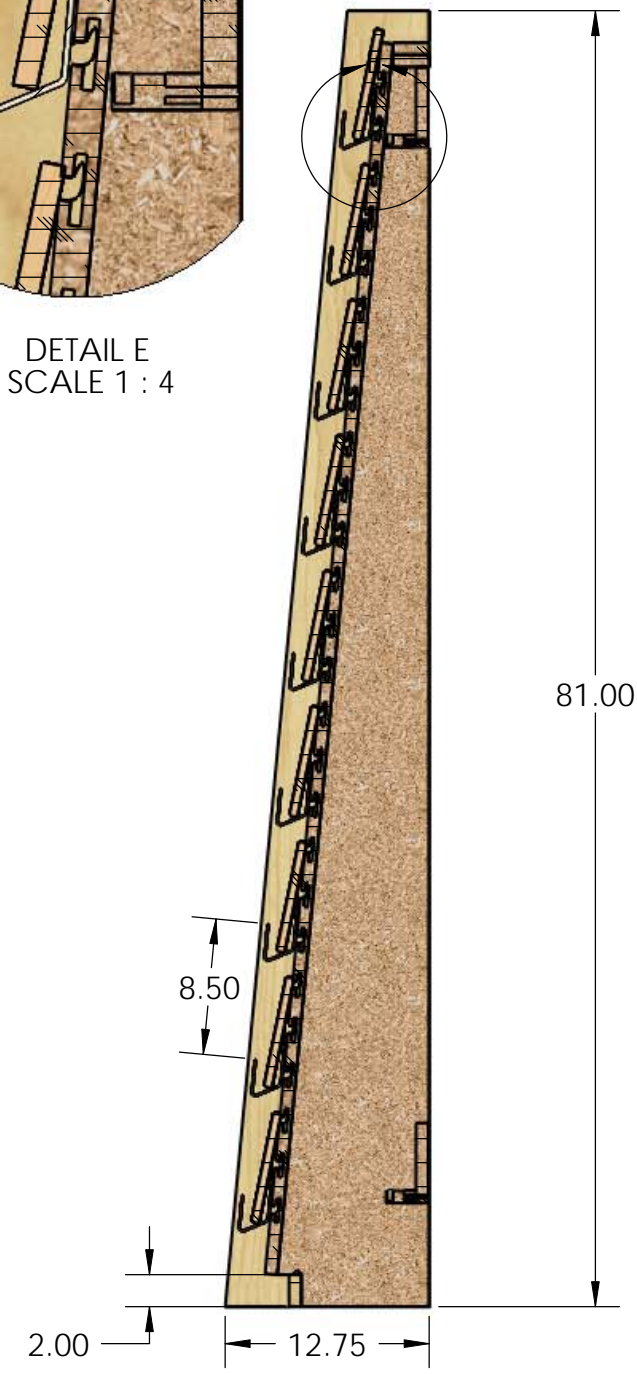

SECTION D-D

SSIA CARD WALL WITH SLATWALL BACK PANEL		QTY:	
DR.BY: <i>CSC</i>	SCALE: 1:12	7/24/2009	1



PHONE: (360) 837-3685 FAX: (503) 255-0025

Finish: See finish options page